



DESCRIPTION	QTY.
2X COMMS (installed by others)	32
TWIN 10A GPO	77
GPO sized by Contractor	13
TWIN 15A GPO	1
LIGHT SWITCH	16
WALL MOUNTED EXHAUST FAN	AS REQUIRED BY SPEC
REV. CYCLE A/C UNIT	BY SPEC
2X1.2M SLIDING WINDOWS	17
1X1.2M SLIDING WINDOWS	2
VERTICAL WINDOW 600X300	3
SMOKE DETECTOR	2
HOSE TAP	2

LEGEND

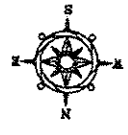


ALL WINDOWS ON THIS SIDE TO HAVE AMPLIMESH SECURITY GRILLS FITTED & IN TOTAL

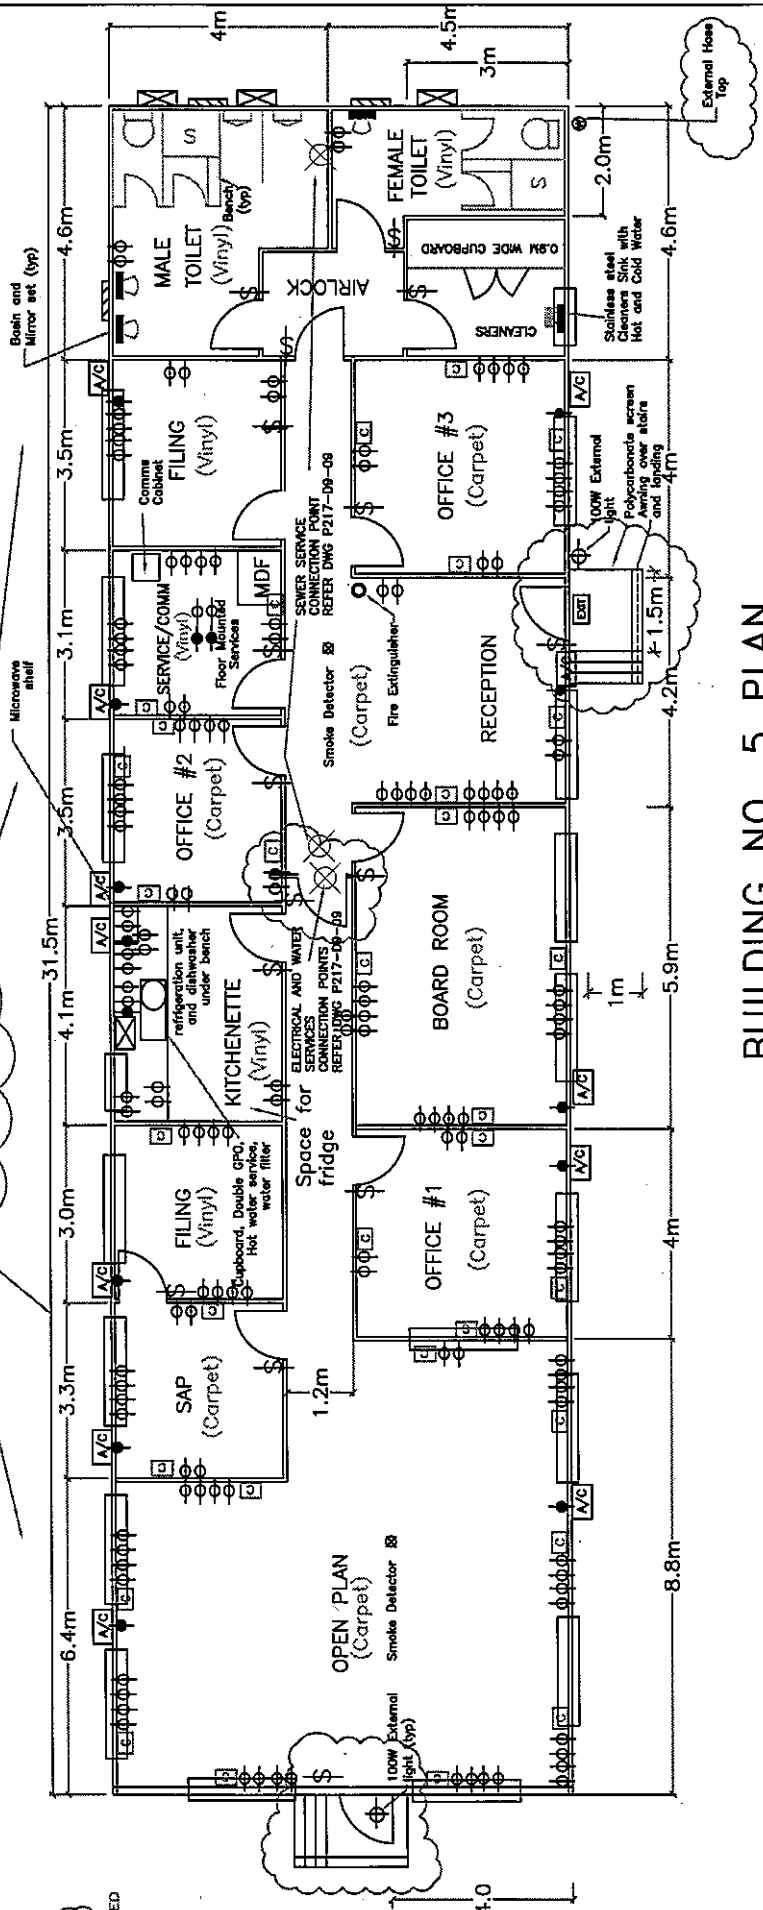

BUILDING NO. 5 PLAN


 Fielder Engineers	233 Pines Highway Andriale NSW 2205 T: 02 8556 2777 F: 02 8556 2788 P: 02 8556 2799 Fielder Engineers Pty Ltd ABN 53 003 476 261 www.fielder.com.au		CONTROLLED DOCUMENT INFORMATION REVISIONS: _____ DESIGNED BY: _____ DRAWN BY: _____ CHECKED BY: _____ DATE: _____	DESIGNED BY: _____ DRAWN BY: _____ CHECKED BY: _____ DATE: _____	DATE: _____ CHECKED: _____ APPROVED: _____	DATE: _____ PRO: _____
	CLIENT: _____	DP: _____ DATE: _____ DESCRIPTION: _____	SCALE: 1:100 SIZE: A3 ALL DIMENSIONS IN MM	C.A.D. FILE: P217\04_Portable Bldg\04-015.DWG DRAWING NUMBER: P217-04-15 SHEET NUMBER: 15 OF 16 REVISION DATE: 21 NOVEMBER 2006 ISSUE: 0		

© Fielder Engineers Pty. Ltd

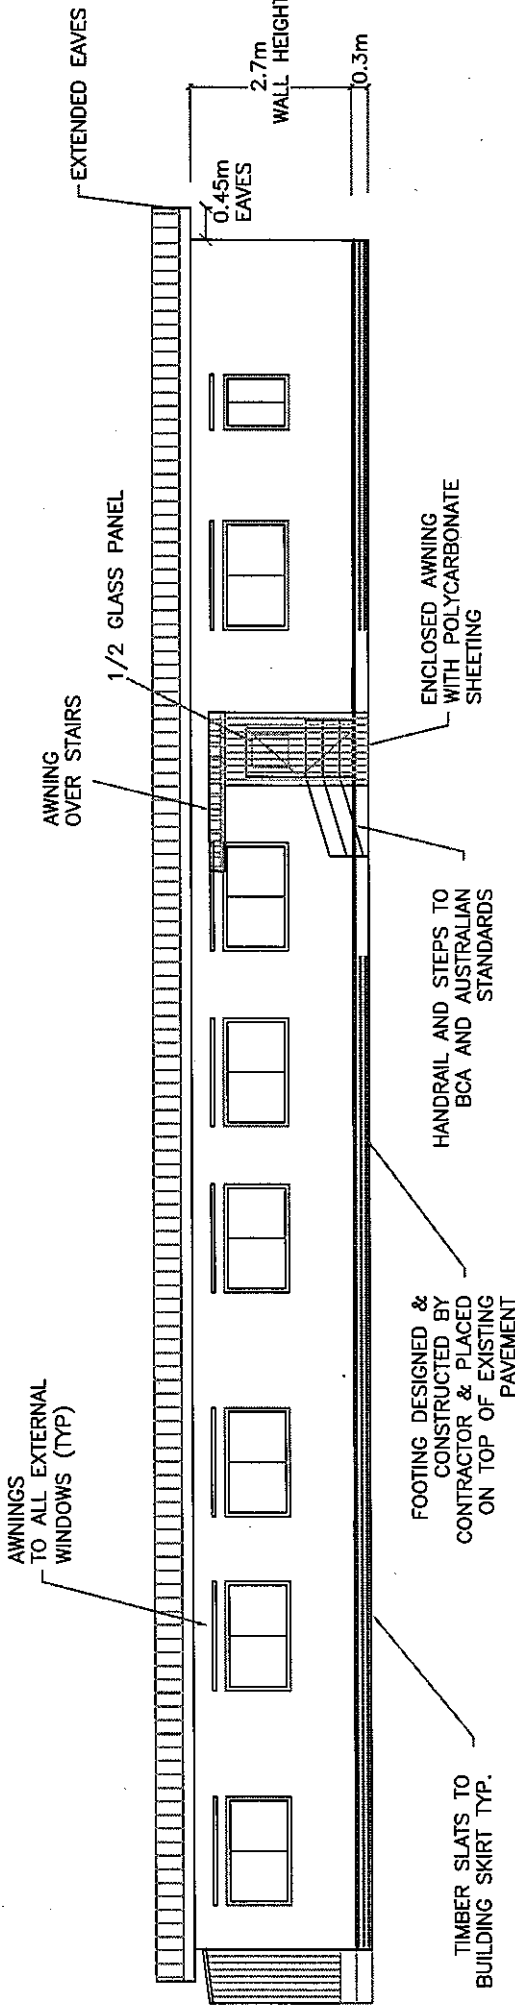

WEST ELEVATION

GUTTER AND DOWNPIPE (TYP)

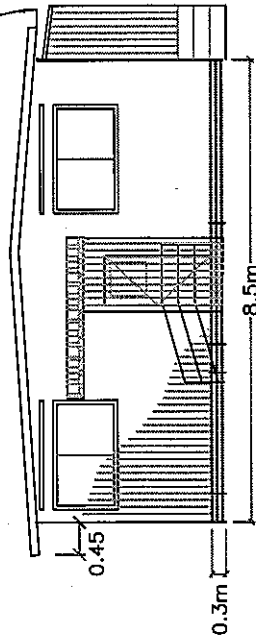

NORTH ELEVATION

233 Princes Highway Arncliffe NSW 2205 P: 02 9358 2766 F: 02 9358 2766 www.fielder.com.au fielder@fielder.com.au www.fielder.com.au		Fielder Engineers 		CONTROLLED DOCUMENT INFORMATION DESIGNED BY: [REDACTED] CHECKED BY: [REDACTED] DRAWN BY: [REDACTED] SCALE: 1:100 ALL DIMENSIONS IN mm		DATE: 28/9/08 CHECKED: APPROVED DATE: 28/9/08 C.A.D. FILE: P217\04 Port Bunk\04-16		DRAWING NUMBER: P217-04-16 SHEET NUMBER: 16 OF 16 REVISION DATE: 21 NOVEMBER 2008 ISSUE: 0	
CLIENT:	DP:	DATE:	SCALE:	DATE:	DATE:	DATE:	DATE:	DATE:	DATE: